

The ideas and designs represented herein and this drawing, all prepared by StudioDFD are for the use solely with respect to this project and StudioDFD shall retain all common law, statutory and other reserved rights including copyright, and they shall not be used by others for any other purpose without written permission of StudioDFD.


Issue	Date

SHEET TITLE

MECHANICAL PLAN

DATE: 09-01-22
 SHEET NUMBER

M 101

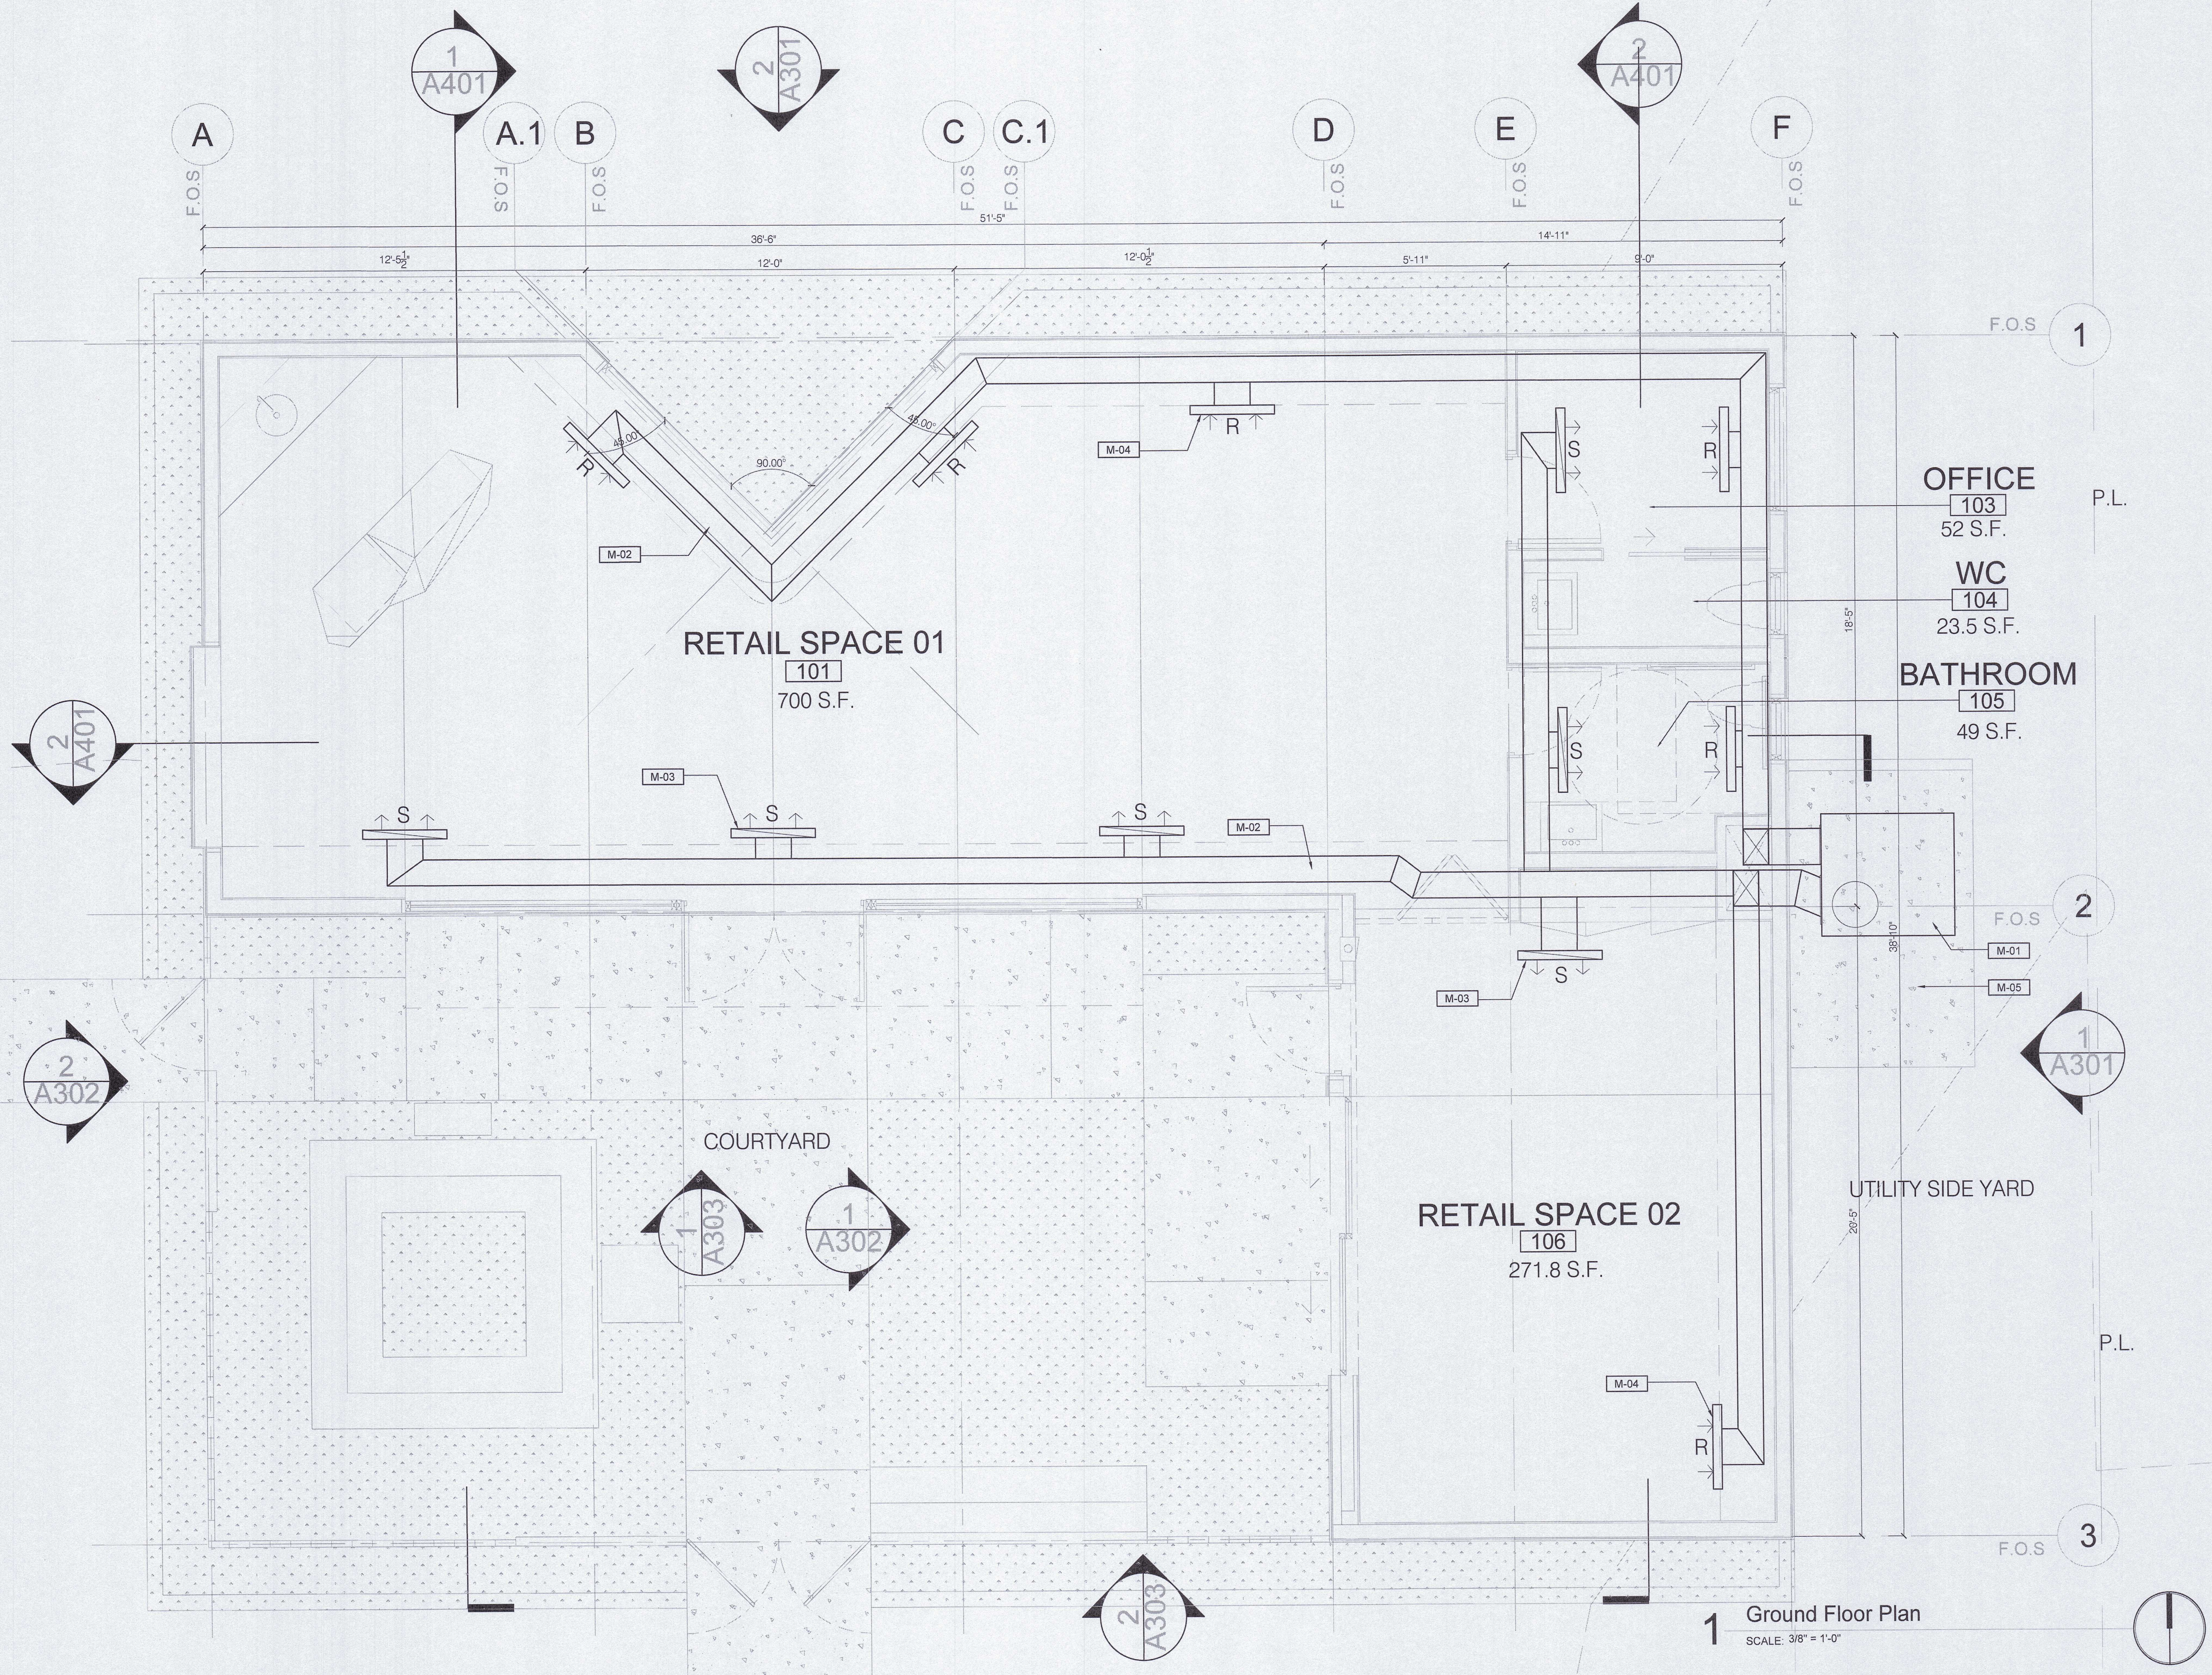

1 Ground Floor Plan
 SCALE: 3/8" = 1'-0"

- GENERAL NOTES**
- KEYNOTES ARE SPECIFIC TO THE DRAWING SECTION IN WHICH THEY RESIDE. ALPHABETICAL PREFIXES IDENTIFY DRAWING APPLICABILITY.
 - ALL DIMENSIONS ARE TO FACE OF STUD (F.O.S.), UNLESS OTHERWISE NOTED.
 - DO NOT SCALE FROM DRAWINGS.
 - ANY INCONSISTENCIES OR UNFORESEEN CONDITIONS TO BE REVIEWED BY THE ARCHITECT PRIOR TO PROCEEDING WITH CONSTRUCTION.
 - GRID REFERENCES AND DIMENSIONS ARE INDICATED FOR REFERENCE ONLY. VERIFY ALL ACTUAL LOCATIONS IN THE FIELD.
 - SPOT ELEVATIONS NOTED ARE FOR REFERENCE ONLY AND ARE CONSISTENT ACROSS ENTIRE FLOOR PLATE UNLESS NOTED OTHERWISE. FIELD VERIFY EXISTING CONDITIONS AND NOTIFY ARCHITECT IN CASE OF DISCREPANCY.
 - COMPLY WITH ALL APPLICABLE LOCAL, STATE, AND FEDERAL CODES AND REGULATIONS PERTAINING TO SAFETY OF PERSONS, PROPERTY AND ENVIRONMENTAL PROTECTION.
 - HOSE BIBS TO BE INSTALLED PER PLUMBING & LANDSCAPE DWGS.

- KEY NOTES**
- M-01 PACKAGE HEAT PUMP- MODEL RQPLB049JK- 46,000 BTU
 - M-02 RECTANGULAR DUCTING
 - M-03 AIR SUPPLY (LINEAR SLOT DIFFUSER)
 - M-04 AIR RETURN (LINEAR SLOT DIFFUSER)
 - M-05 CONCRETE MECHANICAL PAD

- LEGEND**
- CONCRETE PAVING (SLOPE TO DRAIN, REFER TO CIVIL DWGS.)
 - BIORETENTION AREAS (REFER TO CIVIL DWGS.)
 - XERISCAPING AREAS (REFER TO CIVIL DWGS.)
 - PARKING STRIPING