



1 DIESEL CANOPY PLAN
SCALE: 1/8" = 1'-0"

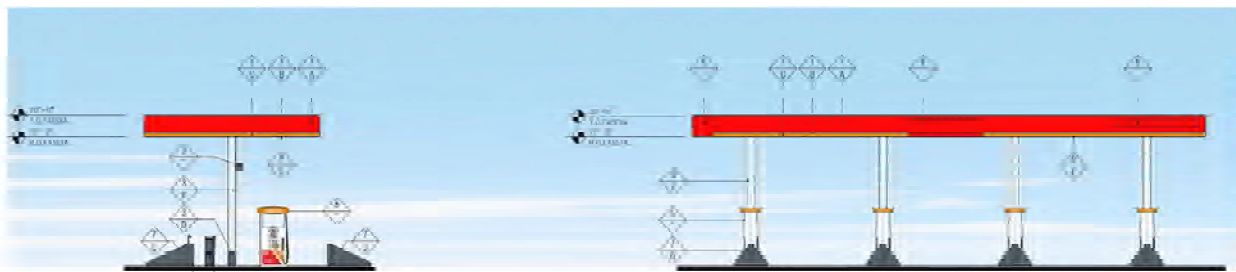

3 'SIDE' ELEVATION (WEST)
SCALE: 1/8" = 1'-0"

2 'FRONT' ELEVATION (SOUTH)
SCALE: 1/8" = 1'-0"

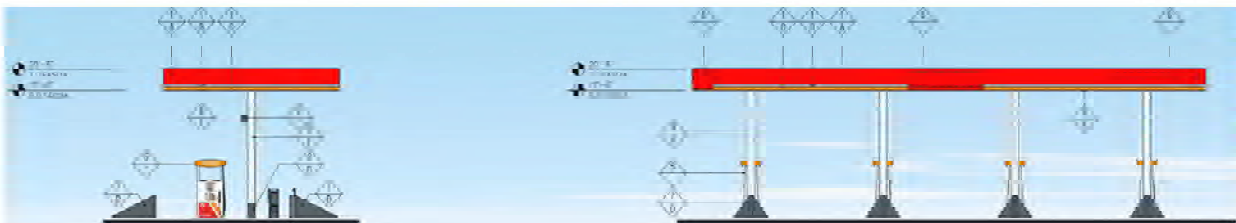

5 'SIDE' ELEVATION (EAST)
SCALE: 1/8" = 1'-0"

4 'REAR' ELEVATION (NORTH)
SCALE: 1/8" = 1'-0"

KEY NOTES

1. MASTER DISPENSER WITH DEF, SEE FUEL DRAWINGS
2. CONCRETE PAVING, SEE CIVIL AND CANOPY STRUCT. DRAWINGS
3. TRUCK ISLAND "PYRAMID" BOLLARD
4. STEEL CANOPY COLUMN, SEE FUEL CANOPY STRUCTURAL DRAWINGS
5. LINE OF CANOPY ABOVE
6. MASTER/ SATellite/ DEF DISPENSER, SEE FUEL DRAWINGS
7. NOT USED
8. 36" HIGH, 5"x5" STEEL POST FOR WATER HOSE BY GENERAL CONTRACTOR
9. YARD HYDRANT - SPEC TED BY GENERAL CONTRACTOR
10. FUEL ISLANDS WHERE REQUIRED
11. PUMP NUMBER BY SIGN VENDOR
12. FIRE EXTINGUISHER, NFPA 10 RATED FIRE CLASS 2A-20B-C MINIMUM. COORDINATE MARKING AND MOUNTING LOCATIONS WITH LOCAL FIRE PREVENTION AUTHORITY AND OX FM.
13. VENT RISER, SEE FUEL PIPING PLANS FOR MORE INFORMATION AND COLUMN LOCATION
14. 3" PVC ROOF DRAIN BY FUEL CANOPY VENDOR
15. AIR UNIT COMPRESSOR FOR HIGH SPEED DIESEL, REFER TO EQUIPMENT SCHEDULE AND ELECTRICAL PRO WORK INFORMATION

rdc.

11221 Freedom Drive #1110
Reston, VA 20190
+ 703.448.0088
rdcalaborative.com

COPYRIGHT NOTICE

This drawing is the property of the above referenced Professional and is not to be used for any purpose other than the specific project and site named herein, and cannot be reproduced in any manner without the express written permission from the professional.

PROFESSIONAL SEAL

REVISIONS	DATE
Δ ISSUE	08/18/22
RS.1	

FINISH SCHEDULE	
▲ FINISH MATTERS:	
1	WELD PAINT, PER-2000
2	EXHIBIT LAGS BY GENERAL CONTRACTOR
3	STEEL COLUMN WITH PAINT FINISH
4	3" x 2" STEEL POST, 36" HIGH
5	FUEL PUMP
6	OPEN DRAIN (CONCRETE VENT)
7	TRUCK ISLAND FORWARD
8	FIRE EXTINGUISHER METAL CANOPY MOUNT
11	AIR UNIT COMPRESSOR FOR HIGH SPEED DIESEL
▼ FINISH COLOR:	
A	CIRCLE K RED #PMS 485
B	CIRCLE K WHITE
C	CIRCLE K ORANGE #PMS 119
D	SHERWIN WILLIAMS - SW6236 - GRAYS HARBOR
E	CIRCLE K BLACK
F	RAL 9010 SHELL WARM WHITE

- Note:
1. Colors shown on these elevations are for illustration purposes only. For actual colors, refer to manufacturer's system.
 2. The finish photos are provided by design vendor.
 3. All colors are subject to manufacturer's availability.
 4. All lighting on canopy from both elevations with access.

PROFESSIONAL IN CHARGE

XX

PROJECT MANAGER

XX

CLIENT / CONTRACTOR

XX

DRAWN BY

XX

PROJECT NAME

CIRCLE K STORES, INC.

1234 STREET ADDRESS
ANYTOWN, US STATE

PROJECT/DATE # RS.1 08/18/22



CIRCLE K STORE INC.

PROJECT NUMBER: XXXX

DIESEL CANOPY PLAN AND ELEVATIONS

A2.4